


REFLECTED CEILING PLAN - AREA "B"
SCALE: 1/8" = 1'-0"

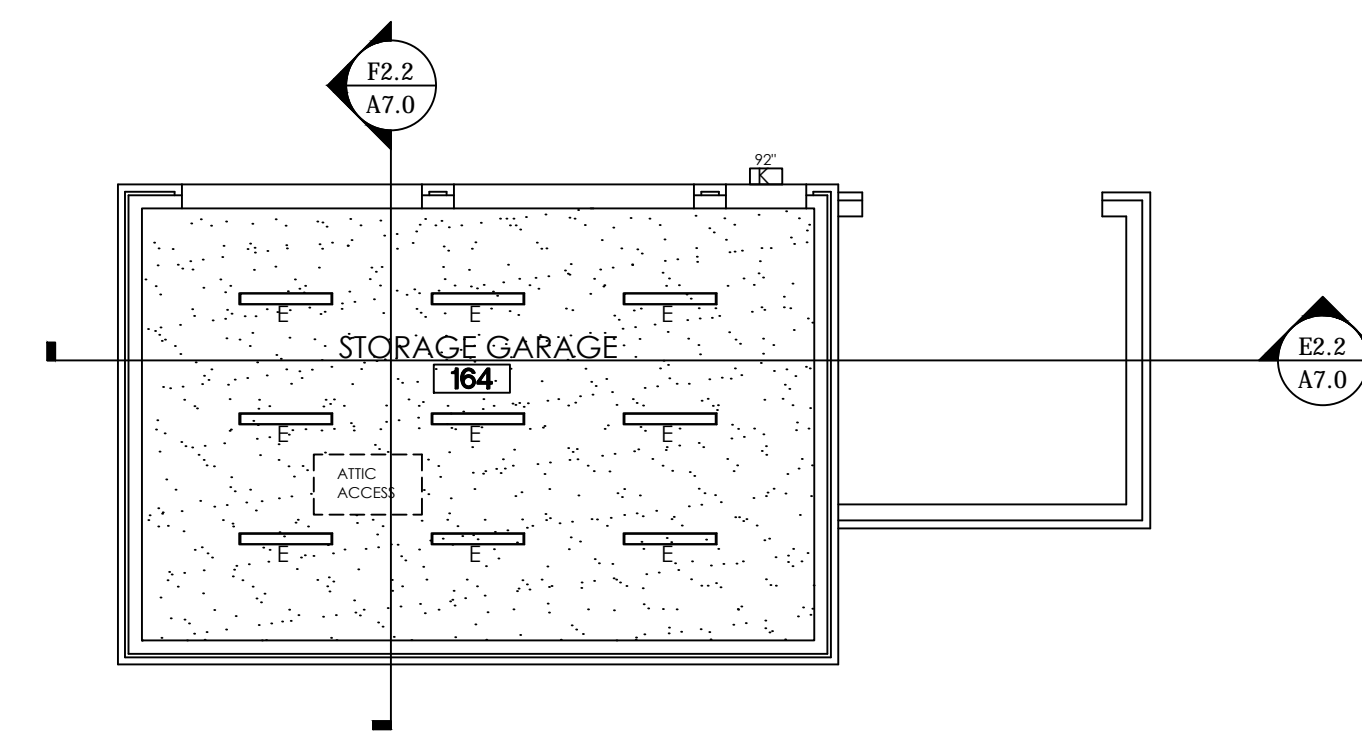

REFLECTED CEILING PLAN - STORAGE GARAGE
SCALE: 1/8" = 1'-0"

REFLECTED CEILING LEGEND


- NON-LOAD BEARING WALL TO TERMINATE INTO CEILING STRUCTURE ABOVE
- 2 HR. FIREWALL - WALL TO TERMINATE INTO ROOF STRUCTURE ABOVE (UL DESIGN NO. U301)
- STRUCTURAL HEADER (SEE STRUCT. DWGS.)
- 1/2" GYPSUM CEILING ON CEILING JOISTS @ 9'-0" A.F.F.
- FIBERGLASS REINFORCED PANEL CEILING @ 9'-0" A.F.F.
- 1/2" GYPSUM RECESSED CEILING ON CEILING JOISTS @ 10'-0" A.F.F.
- INDOOR / OUTDOOR CEILING FAN WITH BUILT-IN LIGHT FIXTURE

LIGHT FIXTURE LEGEND

- LED TRACK HEAD - GREAT ROOM GENERAL LIGHTING, THREE WHITE LIGHT EMITTING DIODES (LEDs), VERTICAL BASE-UP POSITION.
- 4" LED DOWNLIGHT BEDROOMS / CORRIDORS, 3000K LED
- 1X4 SURFACE LED
- 2X4 RECESSED KITCHEN, NICHIA, 757D, 3000K
- LED CEILING PENDANT, LED 3500K
- BATHROOM VANITY
- LED, LOW WATTAGE, EXIT AND EMERGENCY COMBO, WALL MOUNTED FIXTURE
- (3) LEDs, LOW WATTAGE, OUTDOOR EGRESS LUMINAIRE, SURFACE MOUNTED FIXTURE
- 40W 4000K LED WALL PACK
- LED, LOW WATTAGE, DIMMABLE, LOUVERED STEP LIGHT, RECESSED WALL LUMINAIRE


GENERAL RCP NOTES:

- 1) ALL FIXTURE HEIGHTS INCLUDED ON THIS SHEET ARE FROM FINISH FLOOR TO THE BOTTOM OF EACH FIXTURE.
- 2) CONTRACTOR TO COORDINATE ALL WALL LOCATIONS, HEIGHTS & THICKNESSES WITH STRUCTURAL DRAWINGS. CONTRACTOR TO ALSO COORDINATE ALL AITC ACCESS LOCATIONS, HEADER LOCATIONS & SIZES WITH THE STRUCTURAL DRAWINGS.
- 3) CONTRACTOR TO COORDINATE CEILING HEIGHTS IN GREAT ROOMS AND MULTI-PURPOSE ROOM WITH STRUCTURAL DRAWINGS.
- 4) REFER TO MEP DRAWINGS FOR MORE DETAILED SPECIFICATIONS & REQUIREMENTS ON LIGHTING FIXTURES.
- 5) ALL PENETRATIONS THROUGH FIREWALLS AND RATED CEILINGS NEEDS TO BE FIRE SEALED PER CODE TO MAINTAIN THE INTEGRITY OF THE FIRE ASSEMBLY.
- 6) CONTRACTORS TO COORDINATE FAN & LIGHT INSTALLATION AS NECESSARY TO PREVENT OR MINIMIZE THE AMOUNT OF LIGHT STROBING IN ALL GREAT ROOMS.

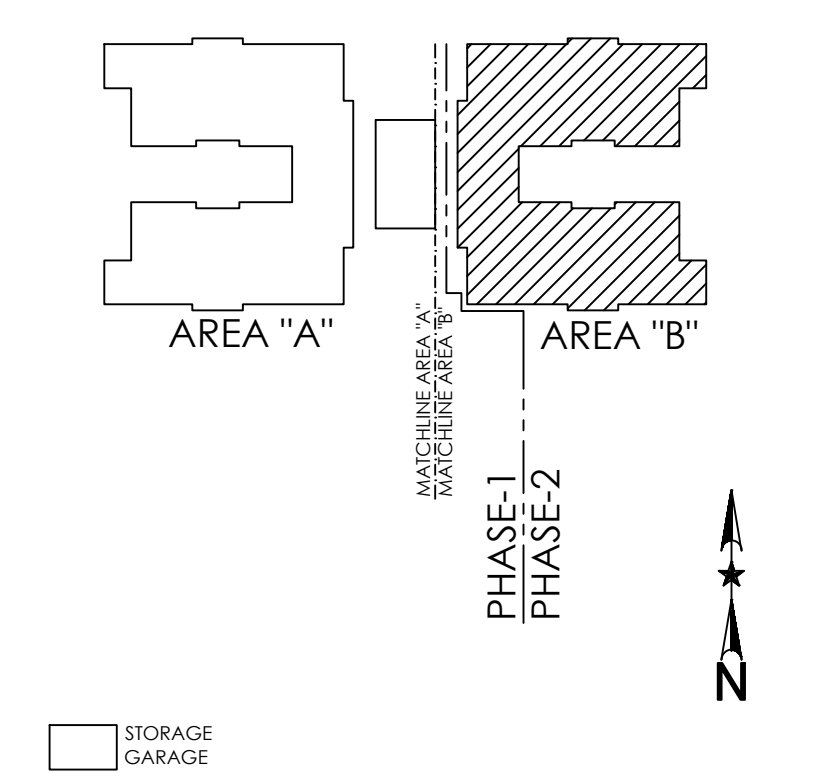


KEY PLAN
SCALE: N.T.S.

**Optimum Personal Care
Assisted Living Phase 2**
1110/12/14 Lakeview Dr.
Sugar Land, Texas 77478

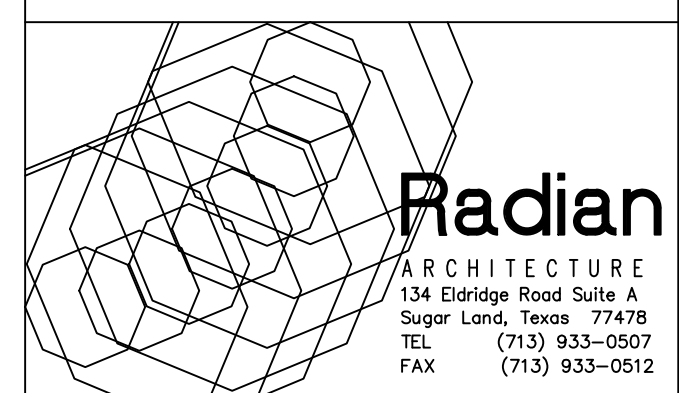

#	Date	Description
1	12.10.12	SCHEMATIC DESIGN
2	02.28.13	50% CONSTRUCTION DOCS.
3	05.30.13	CONTRACTOR SET
4	08.14.13	CONTRACTOR SET - #2
5	08.30.13	PERMIT / TDADS SETS
6	09.10.13	ACI CHANGES
7	11.25.13	TDADS COMMENTS
8	12.10.13	CITY COMMENTS
9	01.23.14	CITY COMMENTS
10	07.17.14	DOORS/WINDOWS REV.
11	08.20.14	FIRE SCREEN WALL
12	10.14.14	PERMIT SET #2
13	07.07.15	GREAT RM. MILLWORK
14	07.10.15	PHASE 2 REVISION
15	09.30.15	CITY COMMENTS
16	05.21.18	PERMIT 3

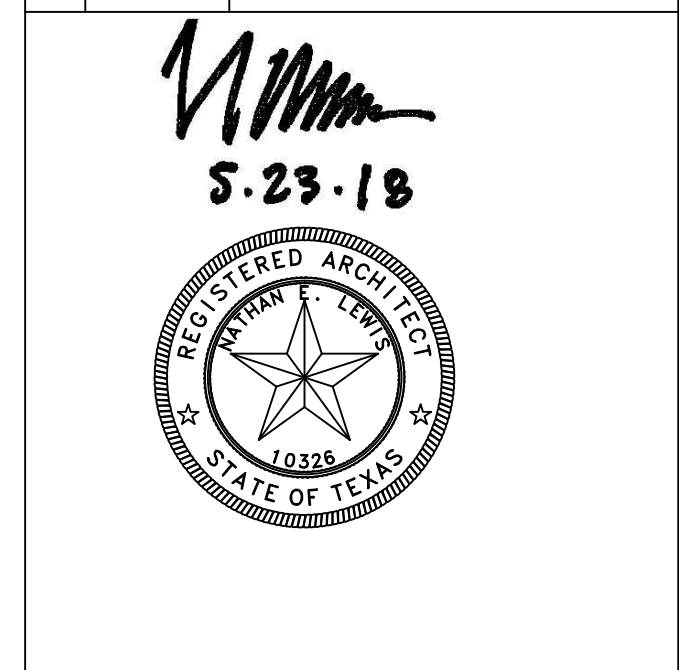

Project No. 1201.31
REFLECTED CEILING PLAN
Sheet No.
A4.1